



**2 GAS CANOPY PLAN**  
SCALE: 1"=20'-0"

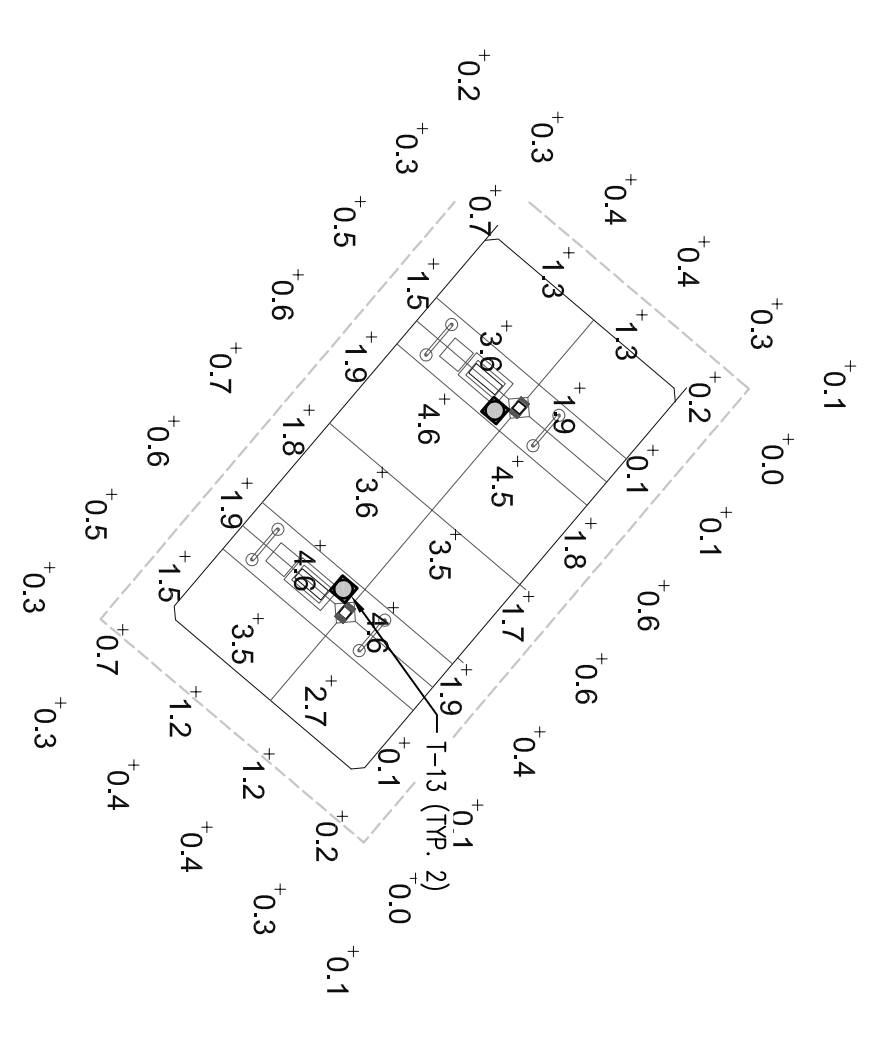

**3 RV CANOPY PLAN**  
SCALE: 1"=20'-0"

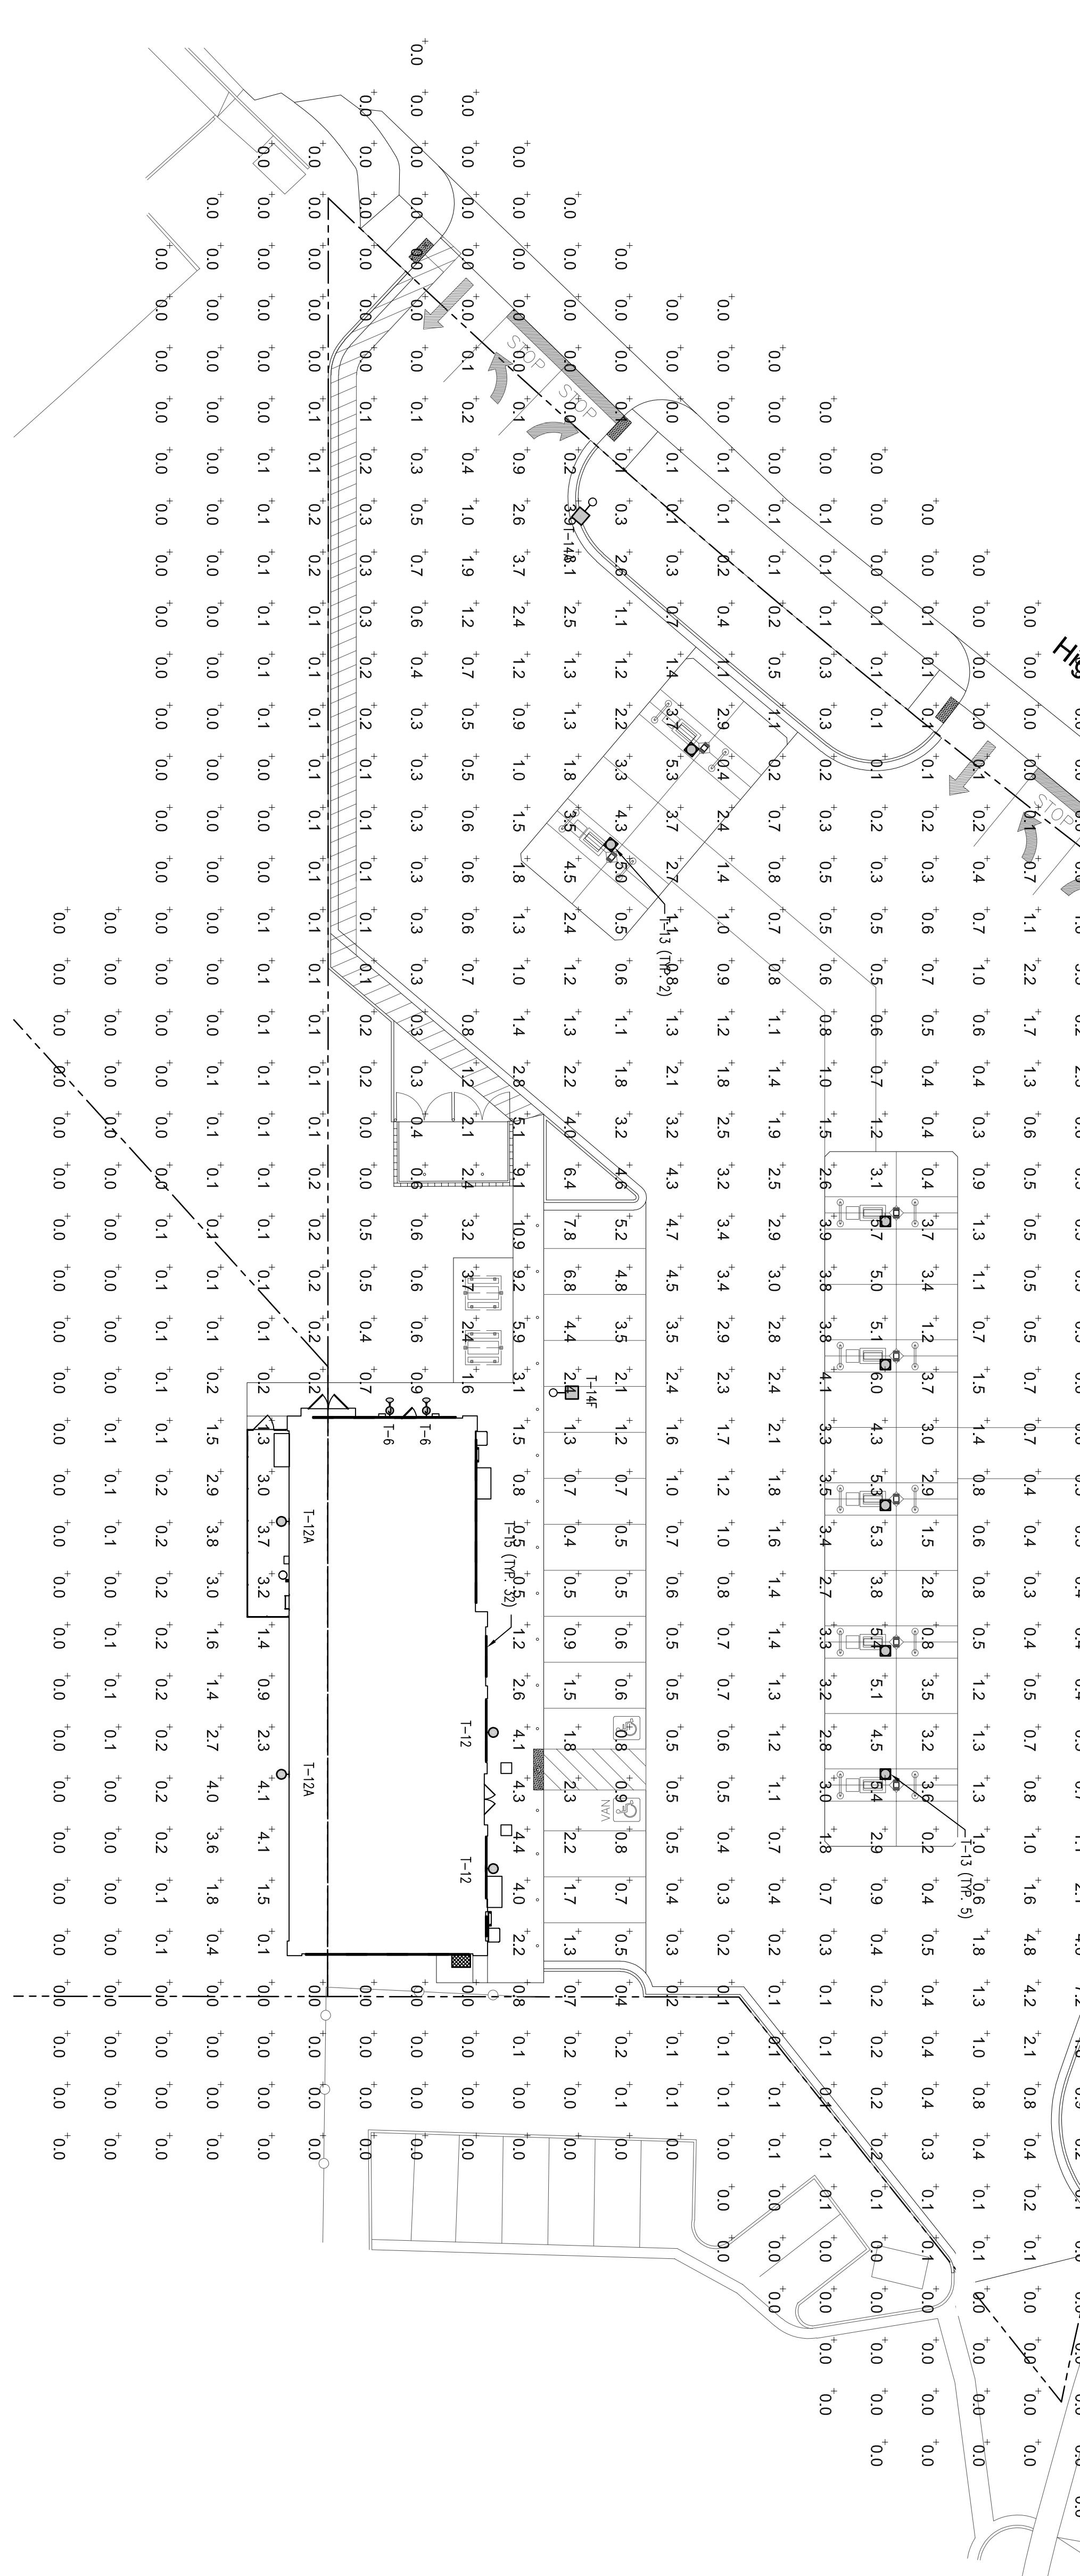

**1 SITE PHOTOMETRIC PLAN**  
SCALE: 1"=20'-0"

**CALCULATION SUMMARY**

AREA NAME	REQD TYPE	SPEC GROUP	ARE	MAX	MIN	MAX/AVG	MIN/AVG
OVERALL SITE	0-0' / H-H	1000	<=>	0.7	10.9	0.0	N/A

**AREA CALCULATION**

AREA NAME	SQUARE FOOTAGE	LUMENREES	LUMENS	FOY	LUMENS/SQUARE FOOT
PARKING	36,877	1-14/14A/14F	9,700/10,400/6,000	2.5/2.1	1.81
GAS CANOPY	3335	1-13	4,541	5	6.42
RV CANOPY	1332	1-13	4,541	2	6.72

**MASTER LUMINAIRE SCHEDULE**

TYPE	MANUFACTURER	CATALOG NUMBER	HOUS	MOUNTING	LAMPS	BALLAST (WATTS)	MAKE
T-6	LED	ANGLE LED LUMINAIRE WITH 23° CROOKED ARM, 1420 LUMENS, 3K, FROSTED GLASS JAR	UNW	WALL	INCLUDED	14	
T-12	LED	DSMW LED 200-1000 30K TM W/OUT DIBZO	UNW	HEIGHT SPECIFIED BY ARCHITECT	INCLUDED	82	
T-13	LED	DSMW LED 200-1000 30K TM W/OUT DIBZO	UNW	HEIGHT SPECIFIED BY ARCHITECT	INCLUDED	29	
T-14	LED	ANGLE LED LUMINAIRE WITH 23° CROOKED ARM, 1420 LUMENS, 3K, FROSTED GLASS JAR	UNW	WALL	INCLUDED	97	
T-15	LED	ANGLE LED LUMINAIRE WITH 23° CROOKED ARM, 1420 LUMENS, 3K, FROSTED GLASS JAR	UNW	WALL	INCLUDED	131	

G:\Maverik\Eden, UT - 18313\Elec\EDEN MODULAR E-1.2.dwg June 18 2018 5:05pm By: jll

SHEET TITLE  
**PHOTOMETRIC PLAN**


**MAVERIK, INC.**  
**STORE #250**  
5100 EAST & 2500 NORTH  
EDEN, UT

**PROJECT NUMBER**  
18313

**ISSUE DATE:**  
June 18, 2018

**REVISIONS:**  
No. Date Description

**Nielson Engineering, Inc.**  
Consulting Engineers  
156 North Twelfth Avenue  
Pocahontas, Idaho 83201  
Ph (208) 232-2377  
FAX (208) 234-0918

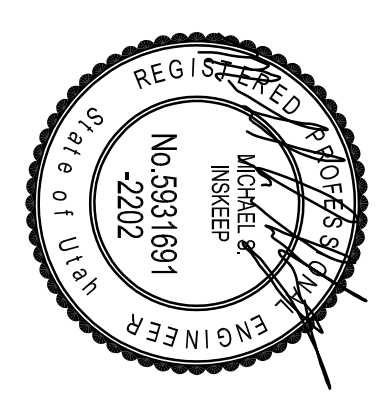

**OWNERSHIP OF DOCUMENTS**  
This document, including the ideas and designs incorporated herein, is the property of Nielson Engineering, Inc. and shall not be used, in whole or in part, for any other project without the written permission of an authorized representative of Nielson Engineering, Inc. Uncolored use will be prosecuted to the fullest extent of the law.  
Copyright © 2018  
By: NIELSON ENGINEERING, INC.

